


Drawn By:
 Checked:
 Approved:

LUFKIN ENGINEERING
 101 N 85th St
 Suite 204
 Seattle, Washington 98103
 (206) 297-9002

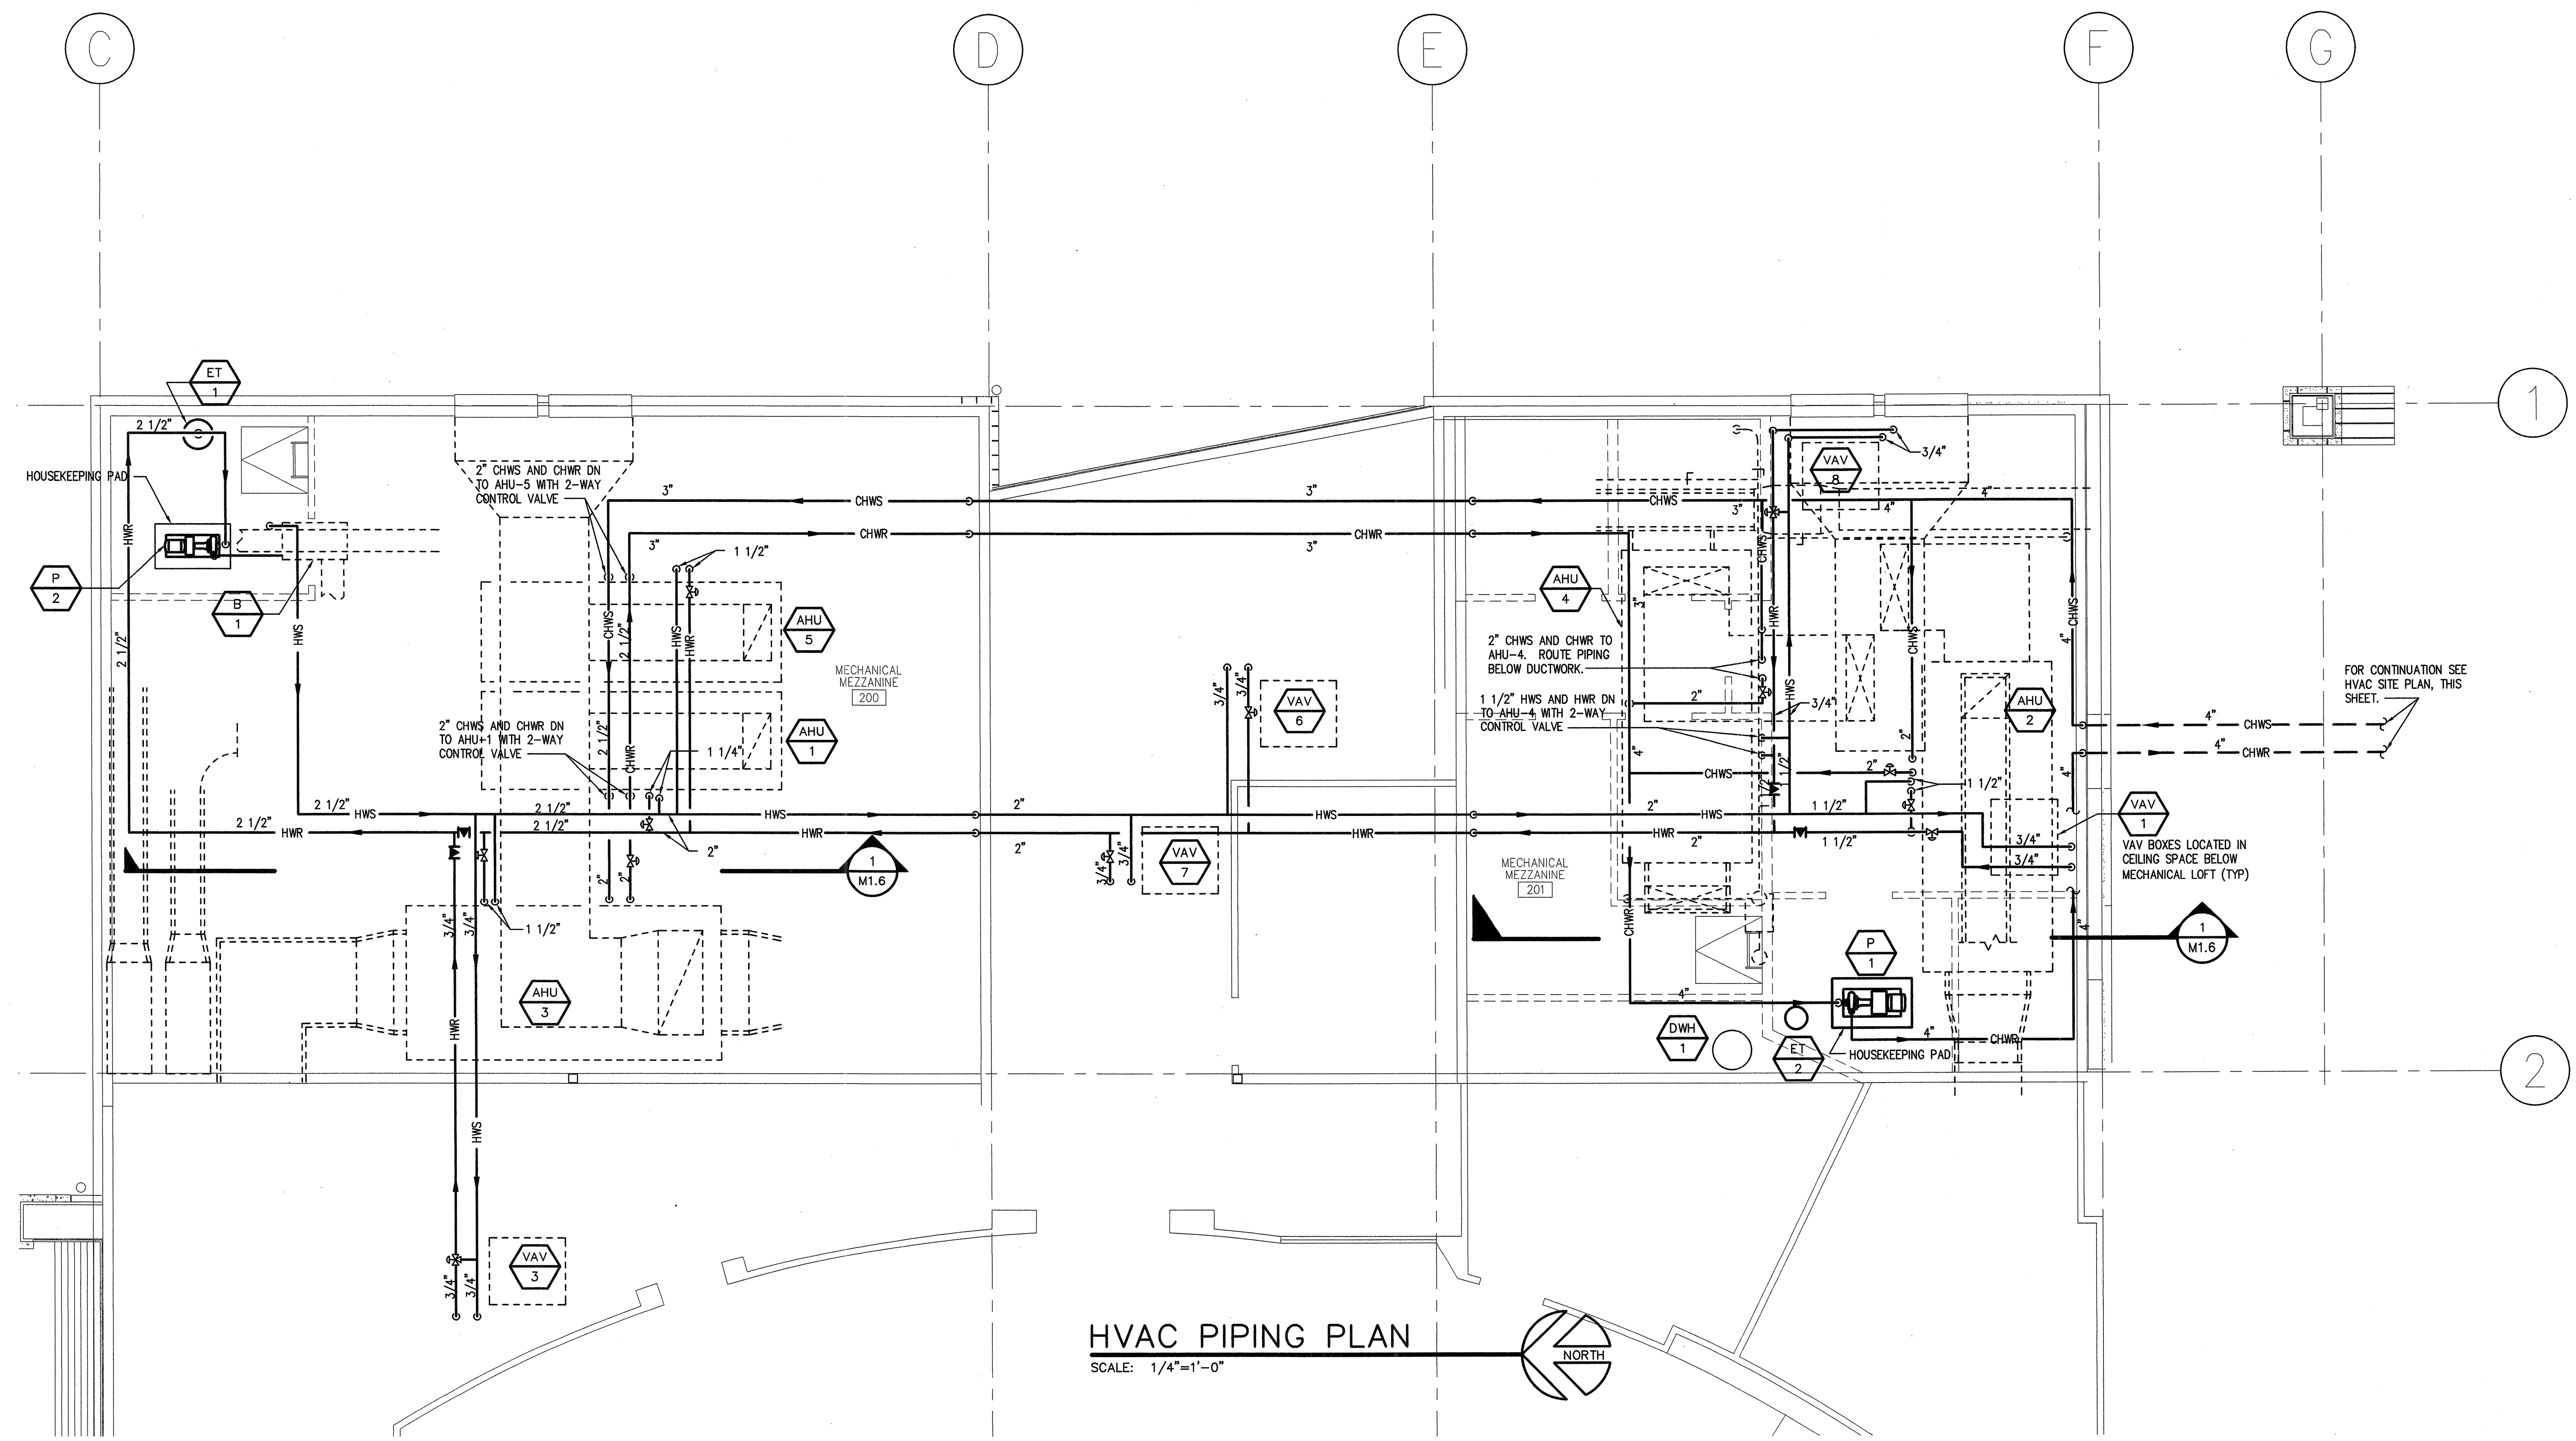

HVAC PIPING PLAN
 SCALE: 1/4"=1'-0"

Issue	Description	Date
1.	CONSTRUCTABILITY REV.	3-25-02
2.	CONSTRUCTABILITY REV.	4-3-02
3.	BID SET	4-22-02
4.	CONSTRUCTION SET	6-28-02

Project Title:

SNOHOMISH LIBRARY


Revision	Description	Date

Sheet Title:
HVAC PIPING


Scale: 1/8"=1'-0"
 Project No: 20022
 Date: 06-28-02

Sheet No:


M1.3
 COVER SET 6-28-02

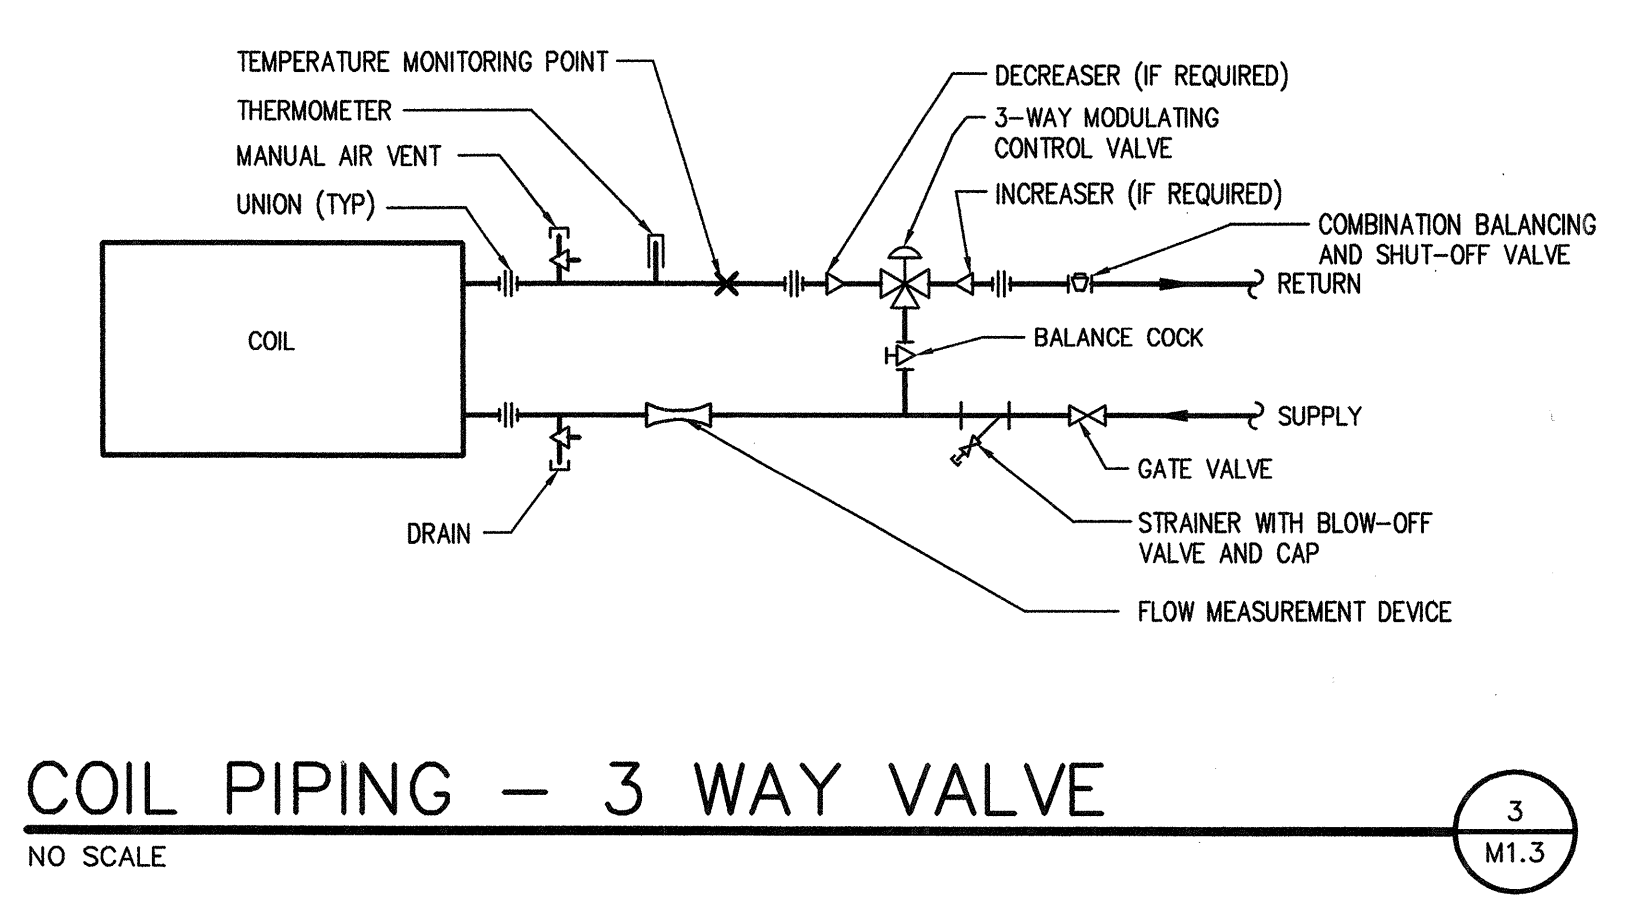

COIL PIPING - 3 WAY VALVE
 NO SCALE

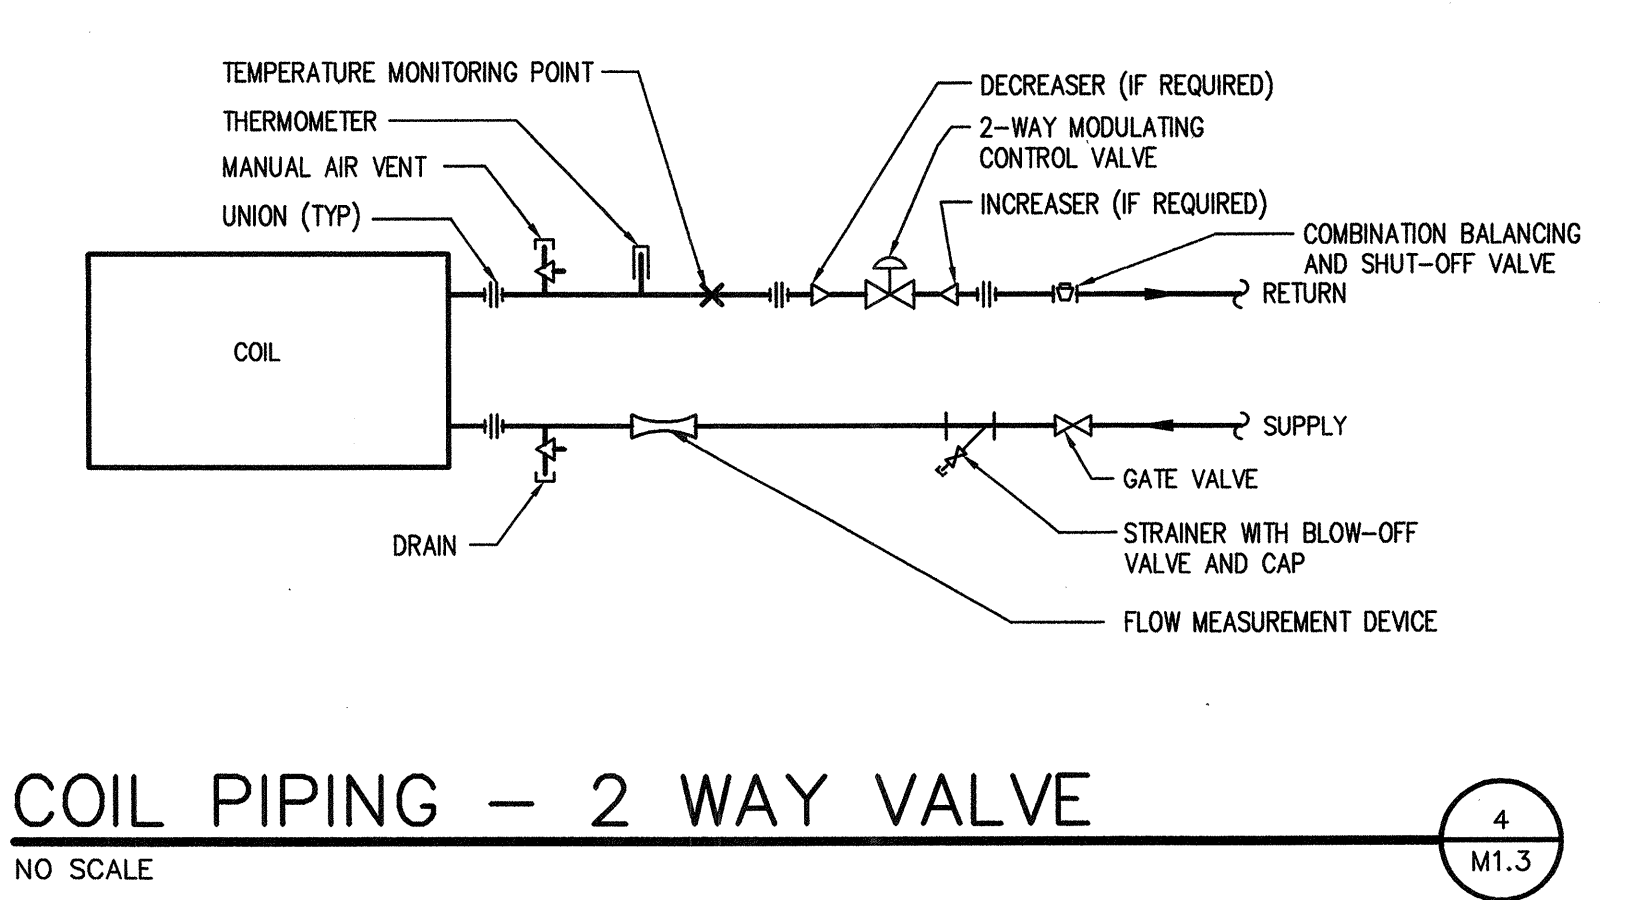

COIL PIPING - 2 WAY VALVE
 NO SCALE

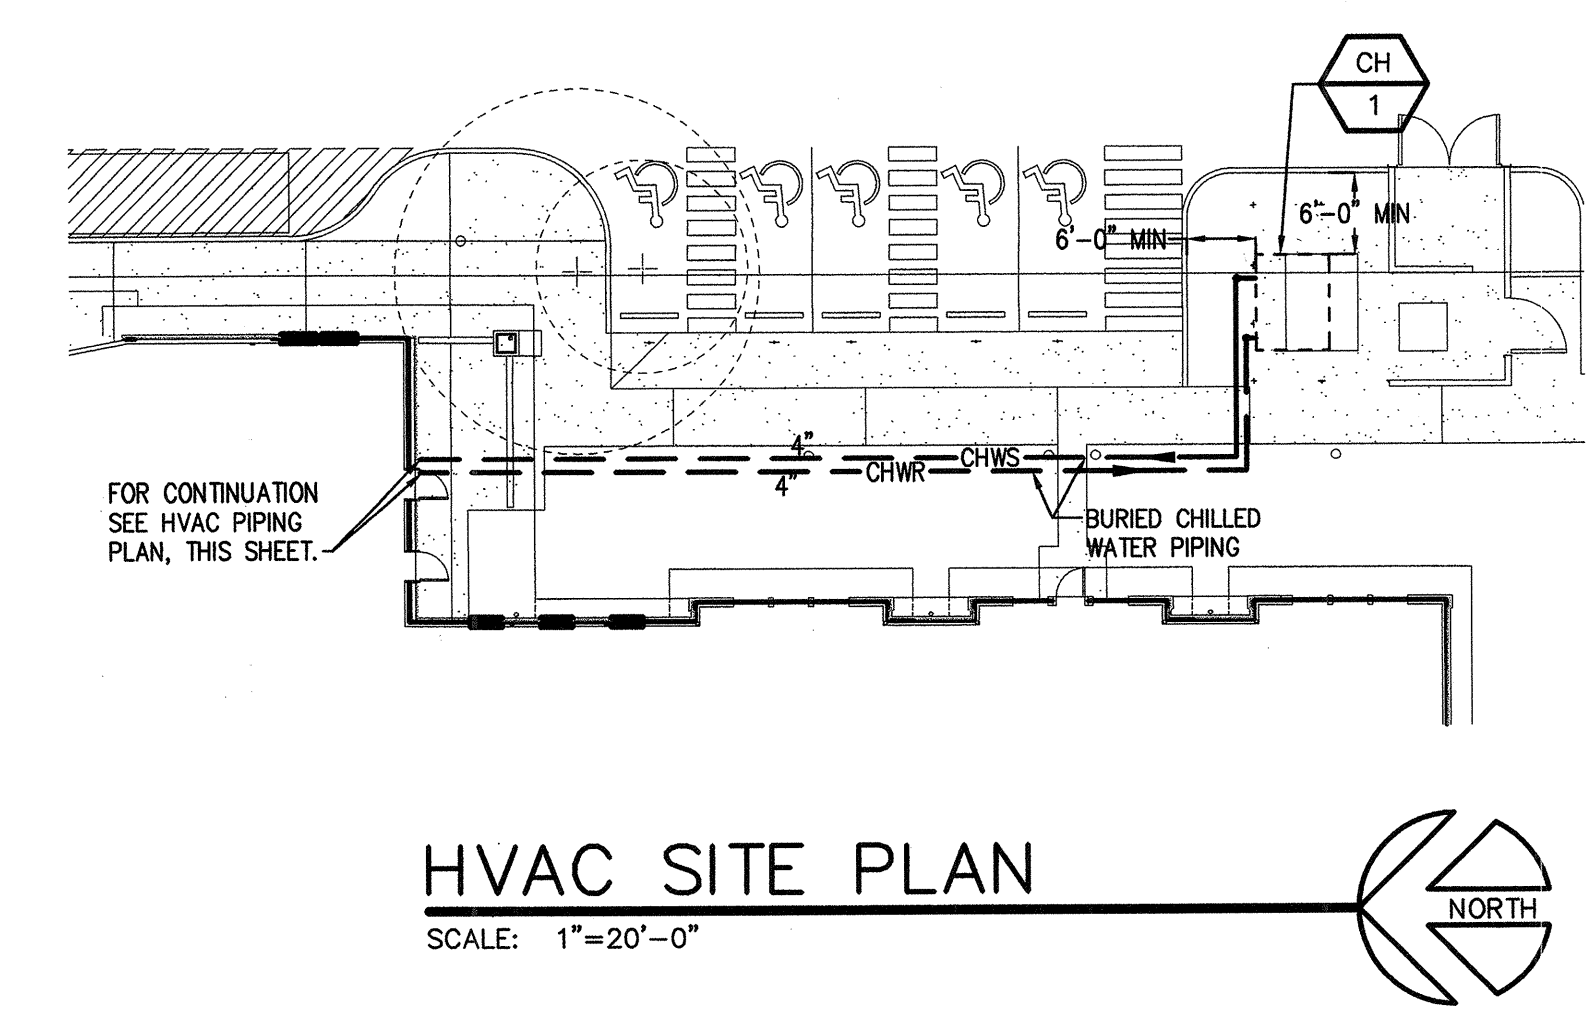

HVAC SITE PLAN
 SCALE: 1"=20'-0"