
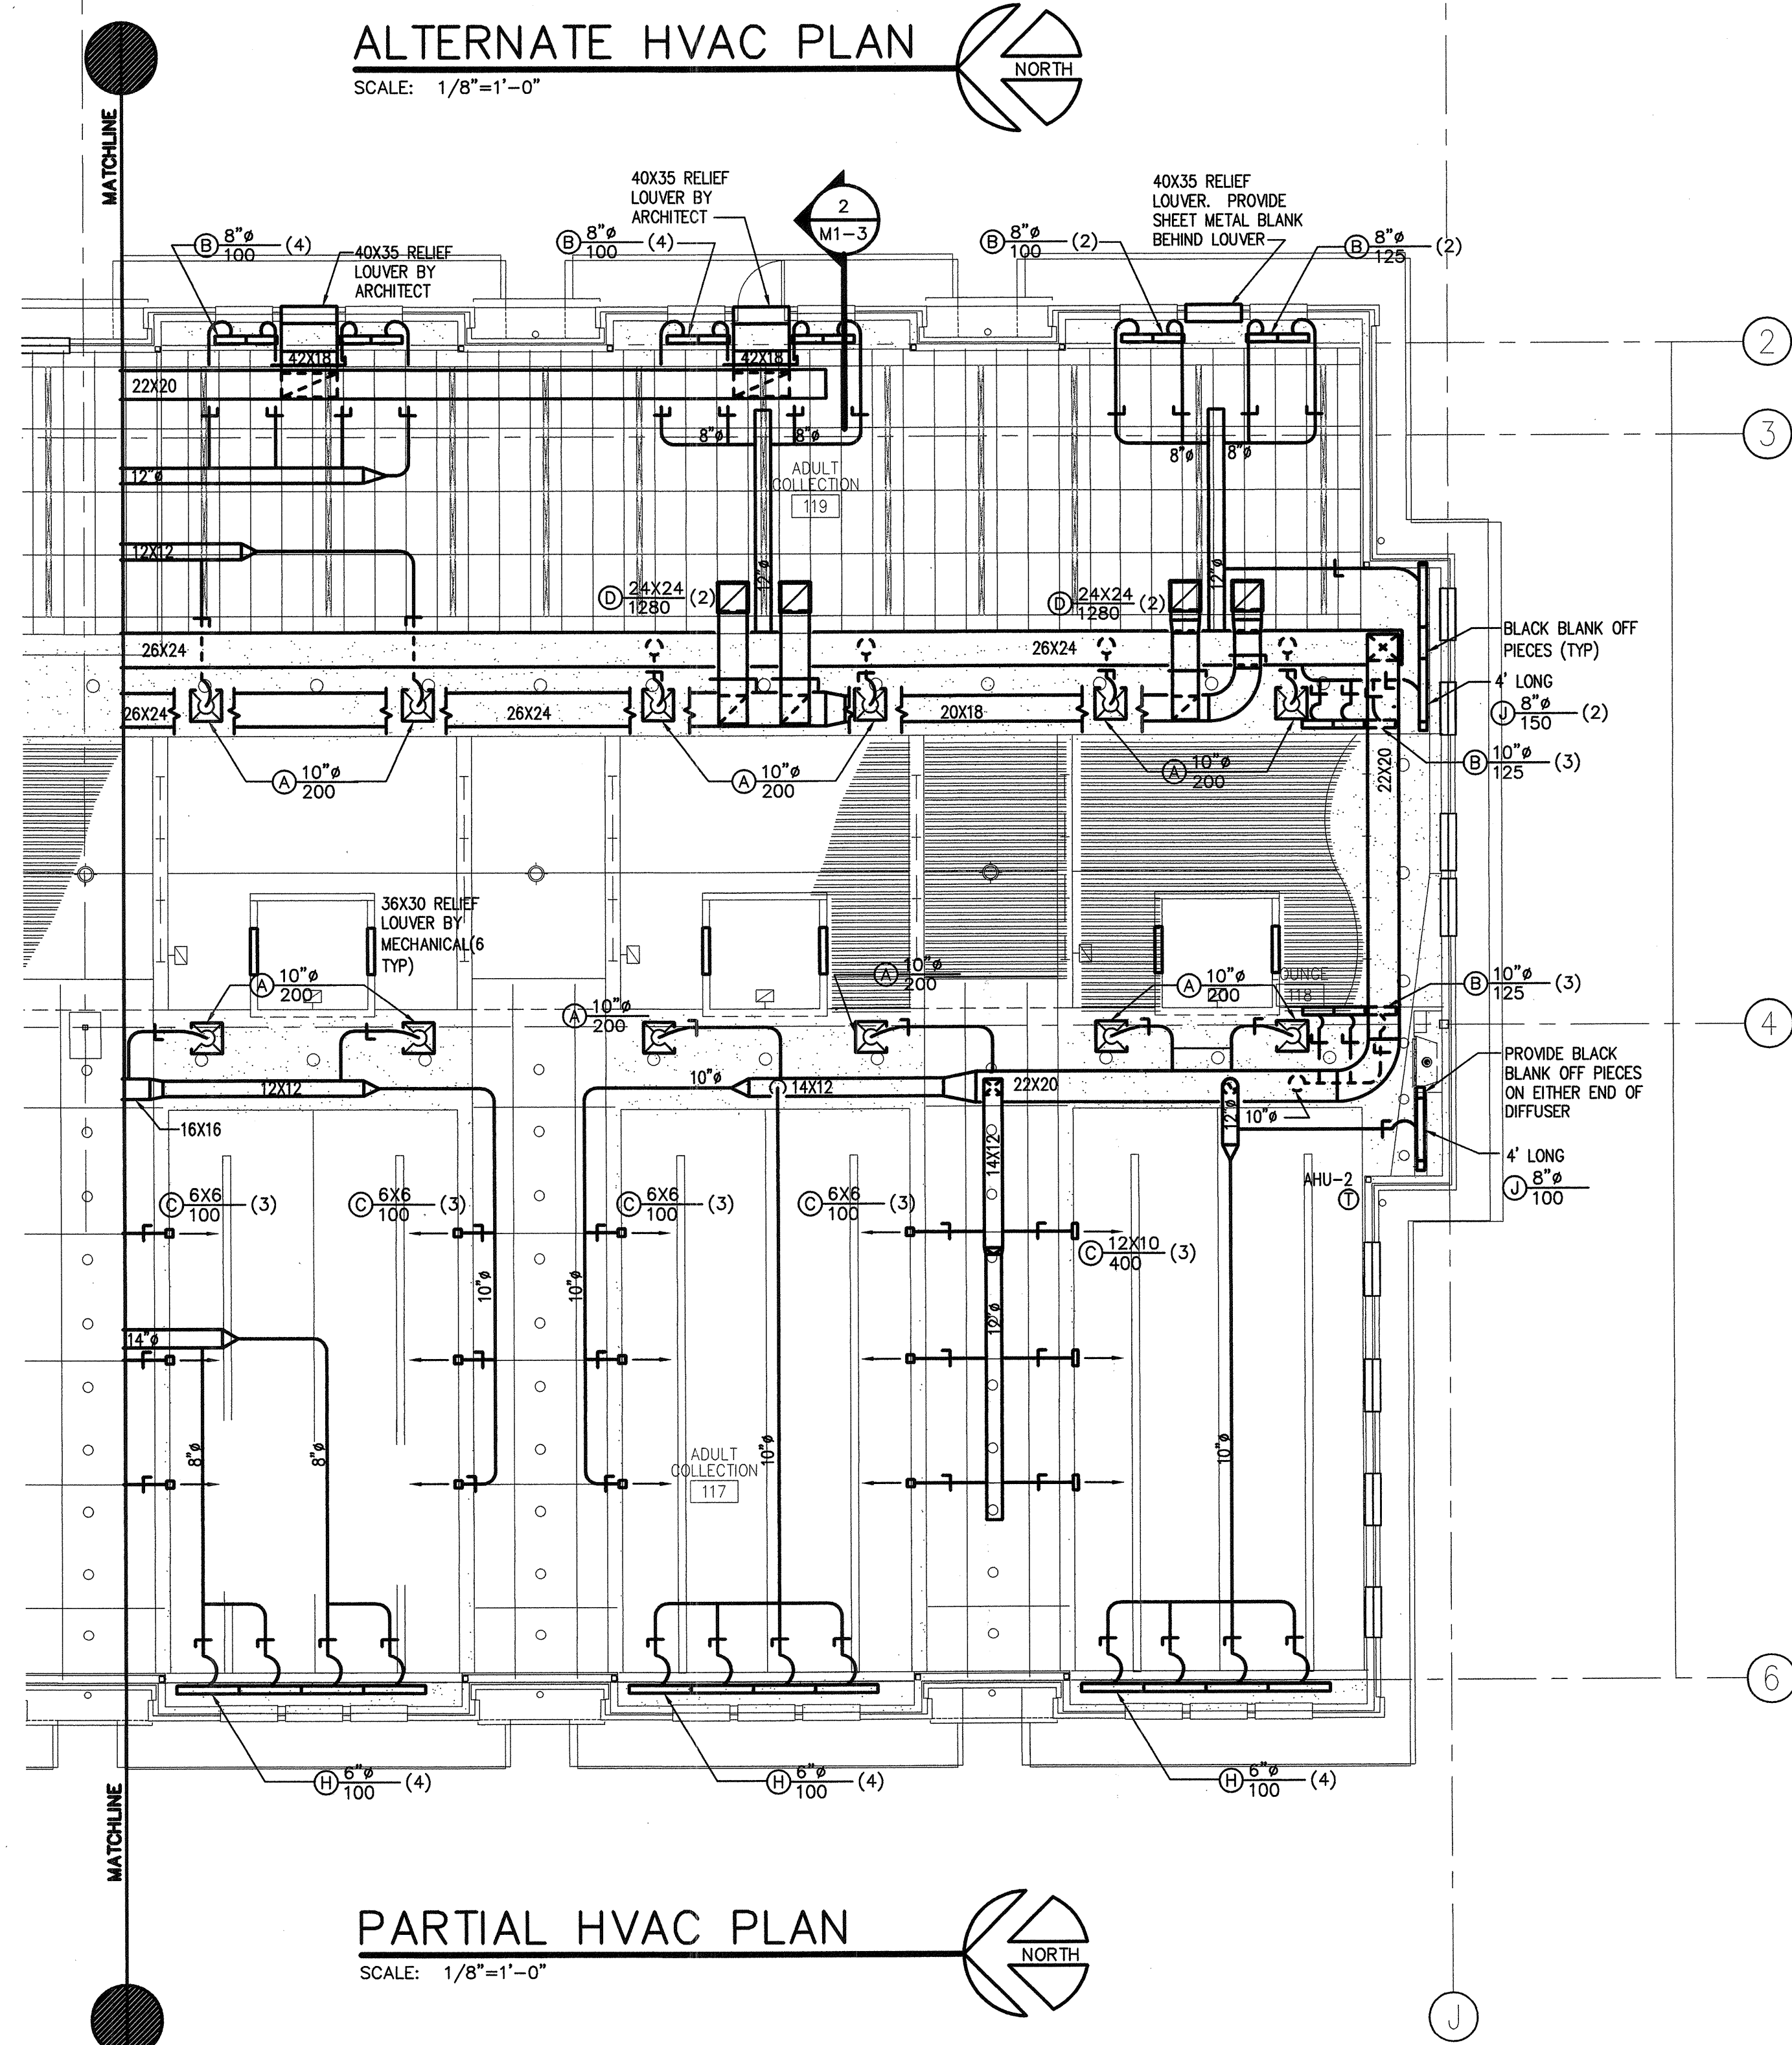



ALTERNATE HVAC PLAN

SCALE: 1/8"=1'-0"

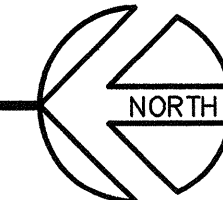

PARTIAL HVAC PLAN

SCALE: 1/8"=1'-0"

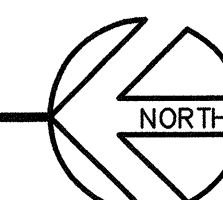

Issue	Description	Date
1.	CONSTRUCTABILITY REV.	3-25-02
2.	CONSTRUCTABILITY REV.	4-3-02
3.	BID SET	4-22-02
4.	CONSTRUCTION SET	6-28-02

Project Title: _____

SNOHOMISH LIBRARY

Revision Description Date

Sheet Title:
PARTIAL HVAC PLAN

Scale: 1/8"=1'-0"
Project No: 20022
Date: 06-28-02

Sheet No: _____

M1.2
CONT. SET 6-28-02