
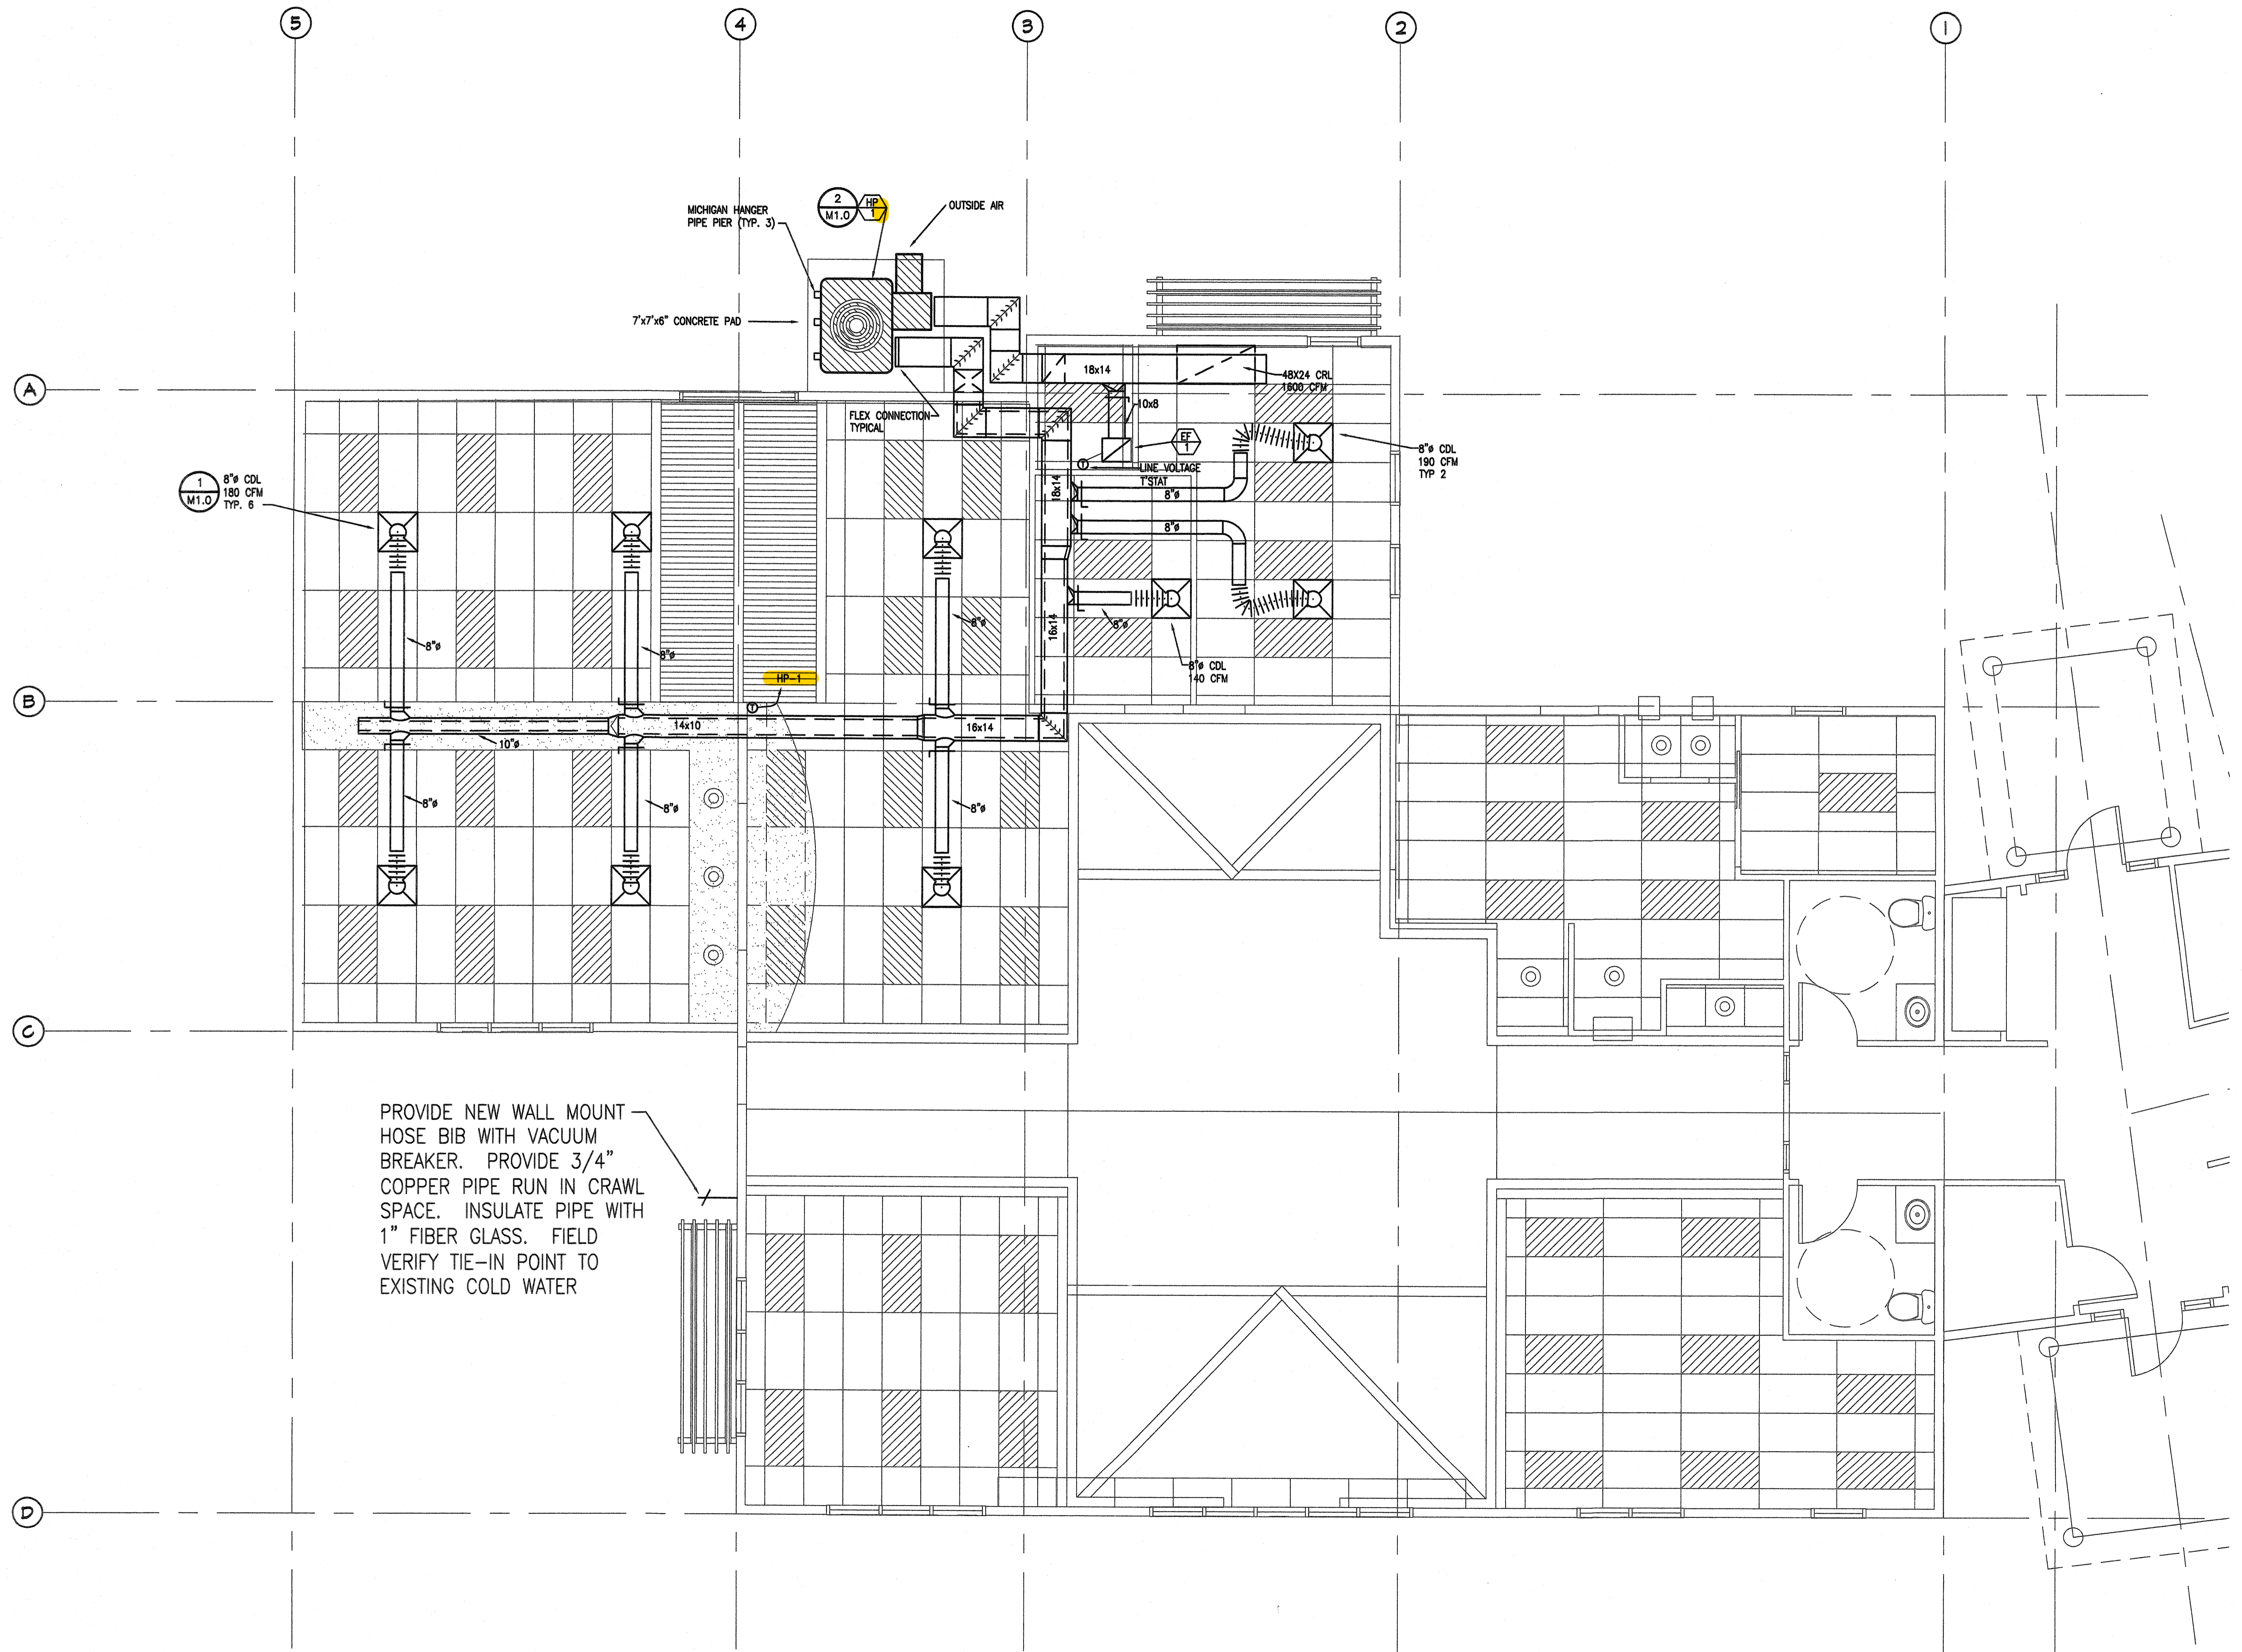


Drawn By: CAL
 Checked: CW
 Approved: CW

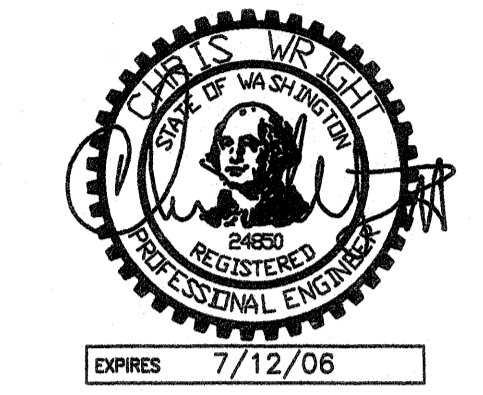

Issue	Description	Date

Project Title: _____

FREELAND LIBRARY EXPANSION

Revision	Description	Date
▲		
▲		
▲		
▲		

Sheet Title: **HVAC**

Scale: 1/8" = 1'-0"
 Project No: 20601
 Date: 05/31/06

Sheet No: _____

M2.0

PLAN NORTH
HVAC PLAN
 SCALE: 1/4" = 1'-0"